



Southlawn Office and Industrial Center Water and Sewer Extension - Alternative 2

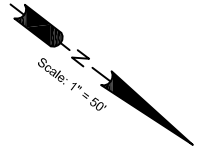

ALTERNATIVE 2 - SITE PLAN
SCALE: 1"=50'

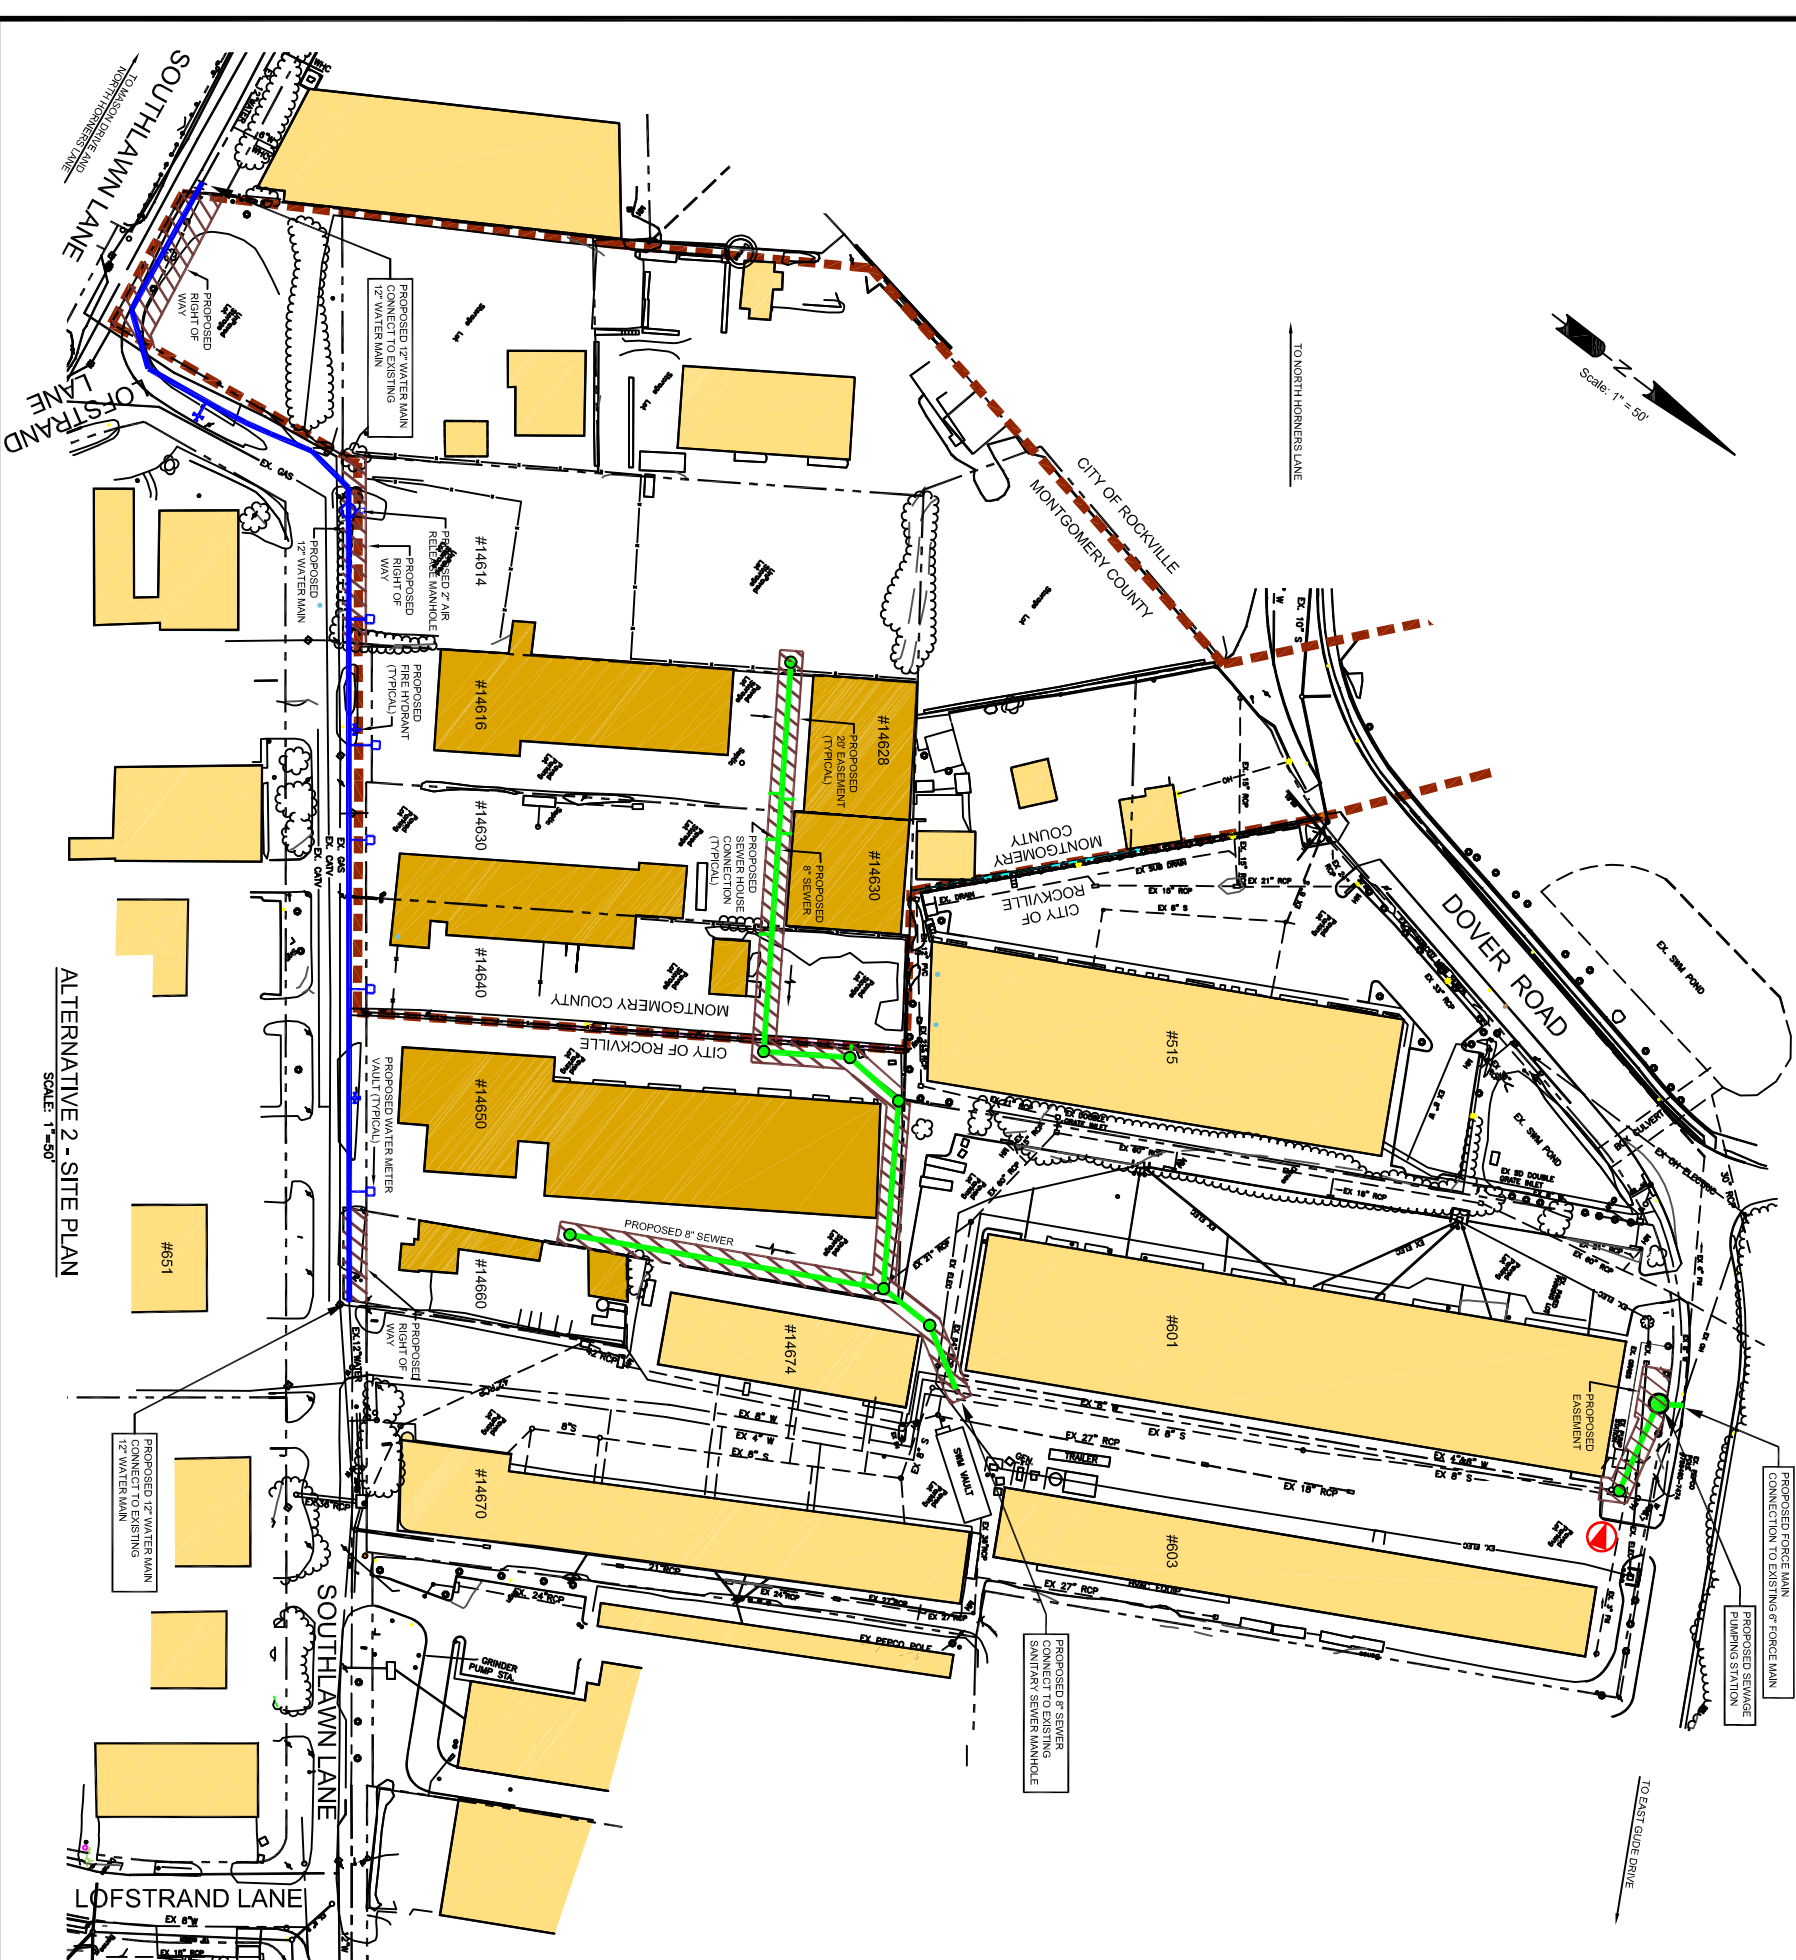

ARTIST'S RENDERING OF PROPOSED SEWAGE PUMPING STATION
ALTERNATIVE 2



▲ = DIRECTION OF PICTURE

NOTE:
RENDERINGS ARE AN ARTIST'S CONCEPTION OF
PROPOSED IMPROVEMENTS AND MAY NOT INDICATE
OF FINAL SELECTED DESIGN OR DETAILED FINISHES.



72 Lorton Circle Baltimore, Maryland 21152-0949